

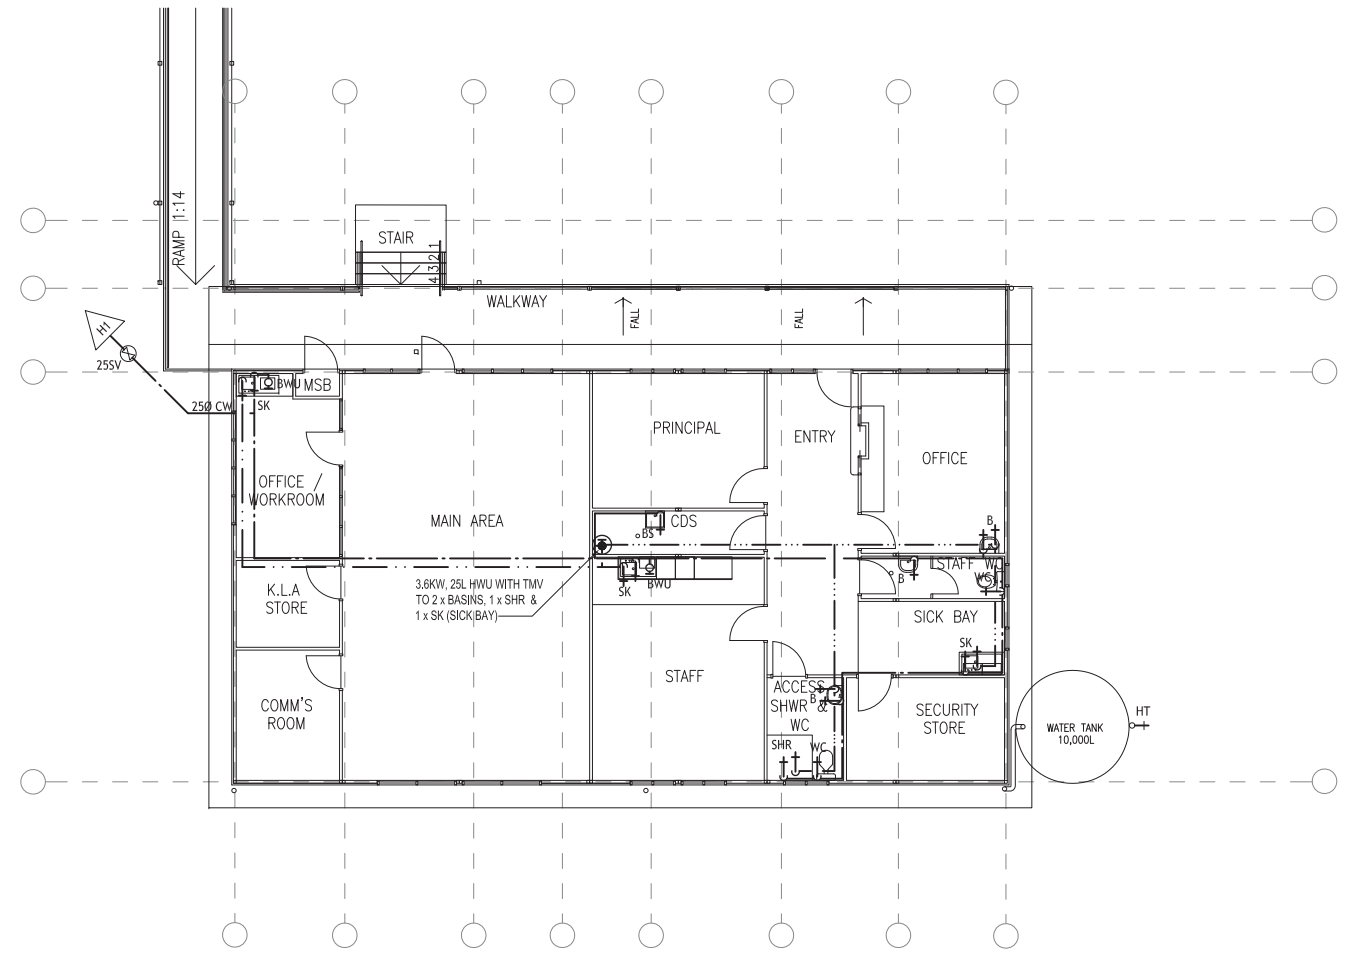


FLOOR PLAN
SANITARY PLUMBING LAYOUT
SCALE 1:100

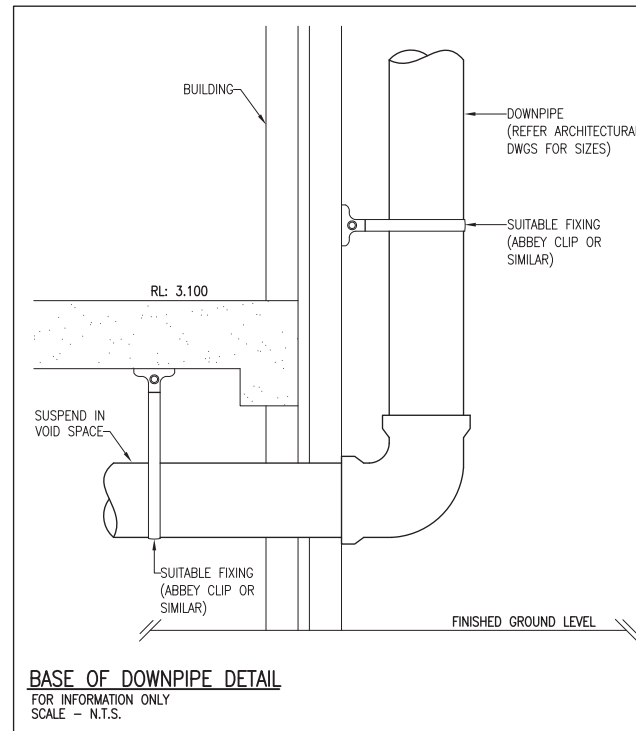


FLOOR PLAN
WATER SUPPLY LAYOUT
SCALE 1:100

AS BUILT BY:
CLW PLUMBING
CRAIG WILLIS
0434 008 989

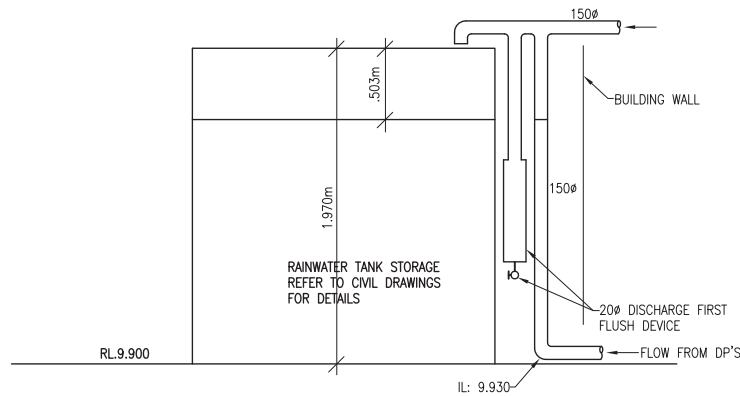

BASE OF DOWNPIPE DETAIL
FOR INFORMATION ONLY
SCALE - N.T.S.


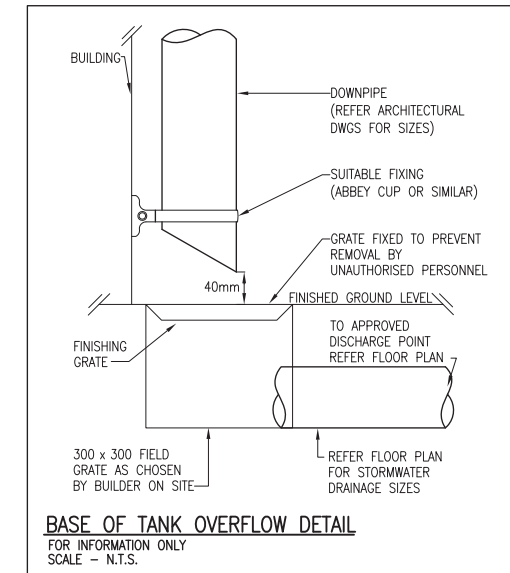


BASE OF TANK OVERFLOW DETAIL
FOR INFORMATION ONLY
SCALE - N.T.S.

REV	DATE	AMENDMENT	BY
A	01.10.09	TENDER ISSUE	CM
B	27.11.09	CONSTRUCTION ISSUE	CM
C	18.03.10	S.W. REDESIGN	GB
D	31.03.10	S.W. REDESIGN	GB
E	19.04.10	SANITARY DRAINAGE REDESIGN	GB
F	23.07.10	AS BUILT	GB

AS BUILT

HYDRAULIC SERVICES
CONTRACT MANAGER

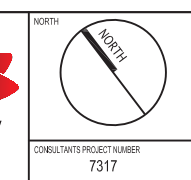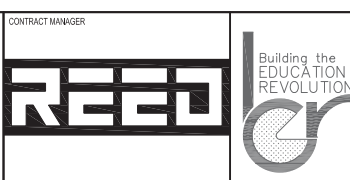

BUILDING EDUCATION REVOLUTION
3 CORE MDR ADMIN/LIBRARY
DURRUMBUL PUBLIC SCHOOL
DURRUMBUL RD, MAIN ARM
HYDRAULIC SERVICES
BLOCK PLAN

0 2 4 6 8 10m			
SCALES (All Original)		DRAFTED DATE	
1:100		29.09.09	
DRAWING NUMBER	DISCIPLINE CODE	BUILDING NUMBER	SERIES NUMBER
1803	AB-HD	32	002
			REVISION
			F